


TREATMENT ROOM	
AST1	AIR STORAGE TANK 100 GALLONS
SPKR	PATIENT COMMUNICATIONS SYSTEM
FP-VR	RF FILTER PANEL - VIEWRAY
FP-S	RF FILTER PANEL - SYSTEM
WAM	WATER AIR MANIFOLD
GTU	GENTRY
LPL	LASER POSITIONING LIGHTS
MAG-PE	MAGNET - PATIENT END
MAG-SE	MAGNET - SERVICE END
PHS-PE	PATIENT HANDLING SYSTEM - PATIENT END
PHS-SE	PATIENT HANDLING SYSTEM - SERVICE END
PHS-DR	PATIENT HANDLING SYSTEM - DRIVE REMOTE
POC	PATIENT OBSERVATION CAMERA
RFS	RF INFRASTRUCTURE
RM	ANNUNCIATOR
ANN	ANNUNCIATOR
APU	AIR PREPARATION UNIT
EQUIPMENT - LOCATED REMOTE	
AC	AIR COMPRESSOR
CH	CHILLER
AST2	AIR STORAGE TANK 200 GALLONS
ORM	OXYGEN MONITOR
OPERATOR ROOM	
OC	OPERATOR CONSOLE
	CENTRAL UNIT INTERCOM
IMEDB	MAGNET EMERGENCY DISCHARGE BUTTON
	HOST COMPUTER
	KEYBOARD
	MOUSE / TRACKBALL
	OPERATOR CONTROL PANEL
	OPERATION UNIT INTERCOM
	PATIENT MONITOR
	SYSTEM MONITOR
EQUIPMENT ROOM	
ACC	ADVANCED CONTROL CABINET
HCU-PE	HELIUM COMPRESSOR - PATIENT END
HCU-SE	HELIUM COMPRESSOR - SERVICE END
HE-PE	HEAT EXCHANGER - PATIENT END
HE-SE	HEAT EXCHANGER - SERVICE END
MMC	MAGNET MONITORING CABINET
PDU	TREATMENT CONTROL CABINET (PDU)
RPFA	RF POWER AMPLIFIER
SEP	SEPARATION CABINET
FA	FILTER ASSEMBLY
APU	AIR PREPARATION UNIT
TCC	TREATMENT CONTROL CABINET

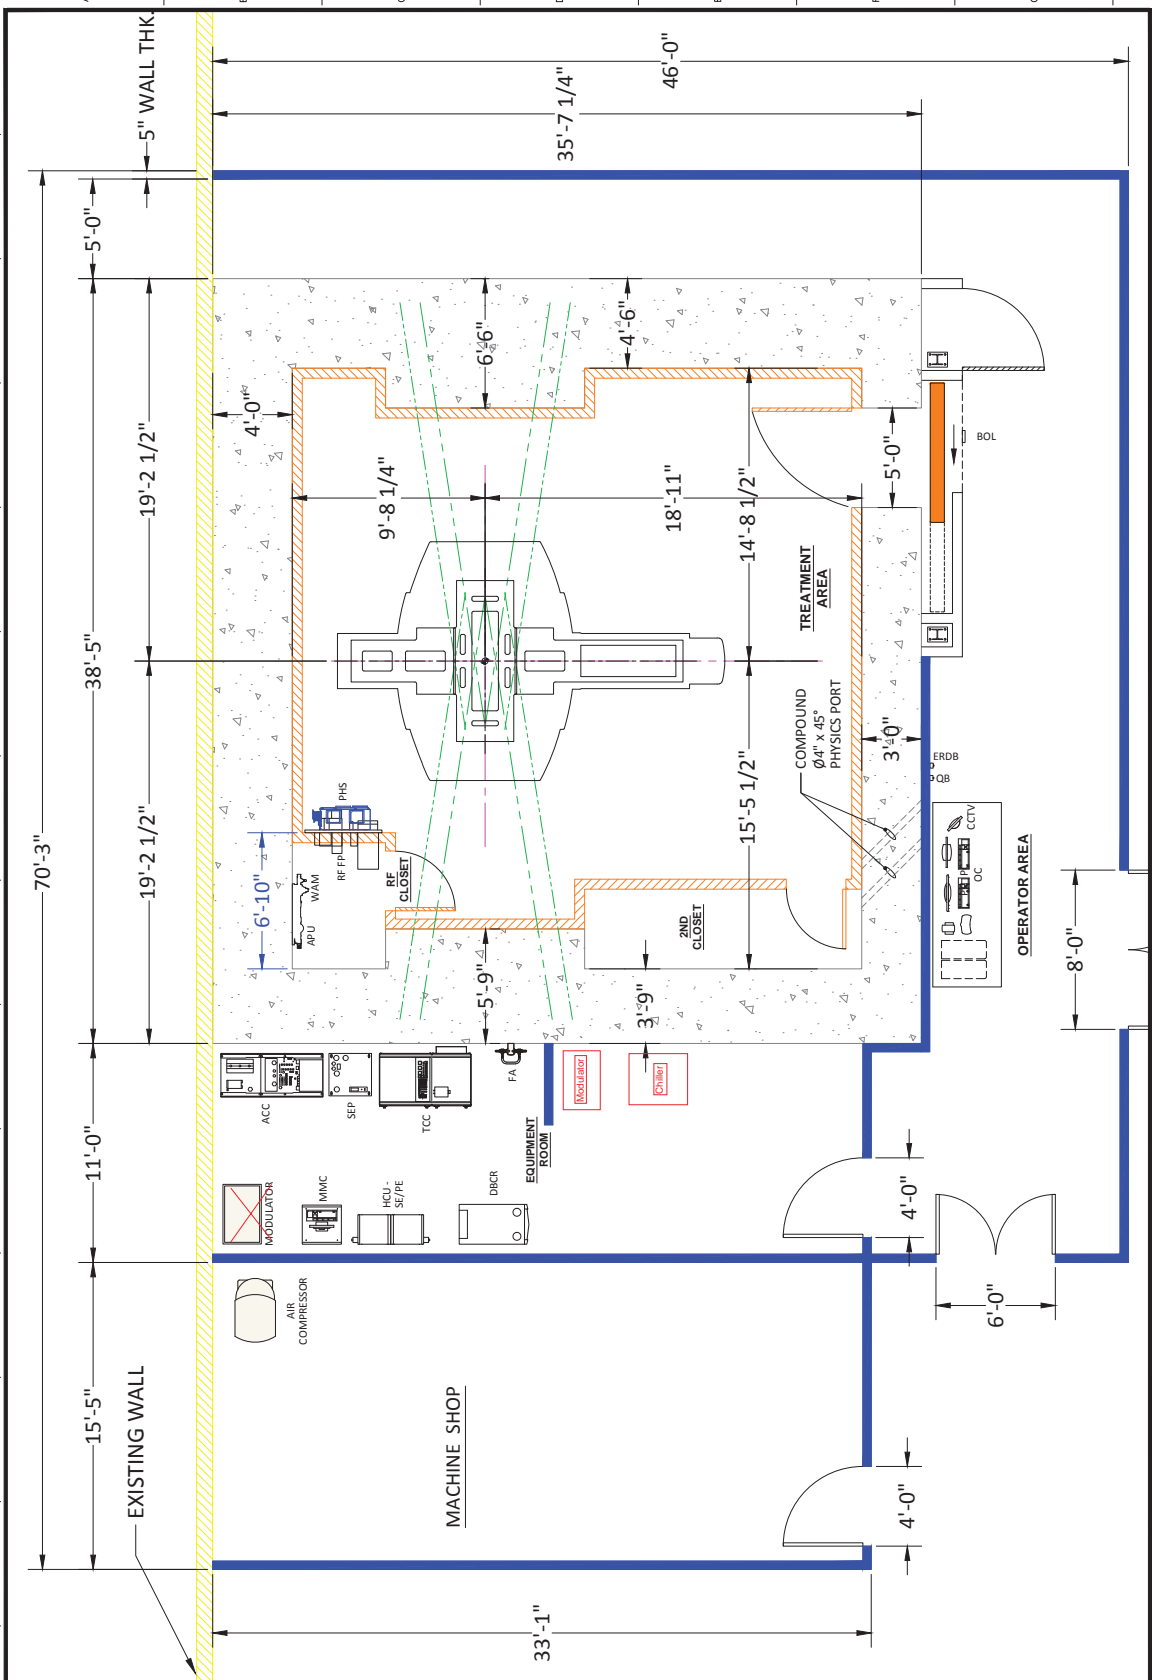

**MRIDIAN**  
BY VIEWRAY

ViewRay Headquarters  
27000 Premier Way, #4106  
Durham, NC 27713  
Phone: +1 480 793 3230  
Fax: +1 800 473 3539

West Coast Office  
10000 W. Alhambra Ave., Suite 100  
Mountain View, CA 94033  
Phone: +1 415 949 3930  
www.viewray.com

**FLOOR PLAN**

DESCRIPTION: MOUNTAIN VIEW TEST VAULT

LOCATION: MOUNTAIN VIEW, CA

SHEET TITLE: VR-A1

REV.	EC NUMBER	DATE	APPROVED	DESCRIPTION

NAME	DATE	DESCRIPTION
T. LUC	01042016	SEE DWG. NO.
R. KESELMAN	01042016	D

DRAWN BY: T. LUC  
APPROVED BY: R. KESELMAN

SCALE: N/A

SHEET 3 OF 21